



ARCWERKS
Incorporated

AA 0002926
Architecture • Planning
21011 JOHNSON ST.
Suite 108
PEMBROKE PINES, FL. 33029
PHONE: (954) 432-8181
E-MAIL:
info@arcwerks.com
WEBSITE:
www.arcwerks.com

SEAL:

ERIC T. SLAZYK #AR13260

PROJECT:
Proposed Building For
International Union of
Operating Engineers

ADDRESS:
19700 SW 68 Ct.
Pembroke Pines, FL 33332

ISSUE	
1	09.29.20 Folding Partitions Review
2	
3	
4	
5	
6	
7	
8	
9	
10	


REVISION	
1	
2	
3	
4	
5	
6	
7	
8	
9	
10	

PROJECT PHASE
Construction Documents

DRAWING TITLE
Floor Plan
Scheme "A"

PROJECT NUMBER
18-230
DATE
September 29, 2020
DRAWING NUMBER

A-1

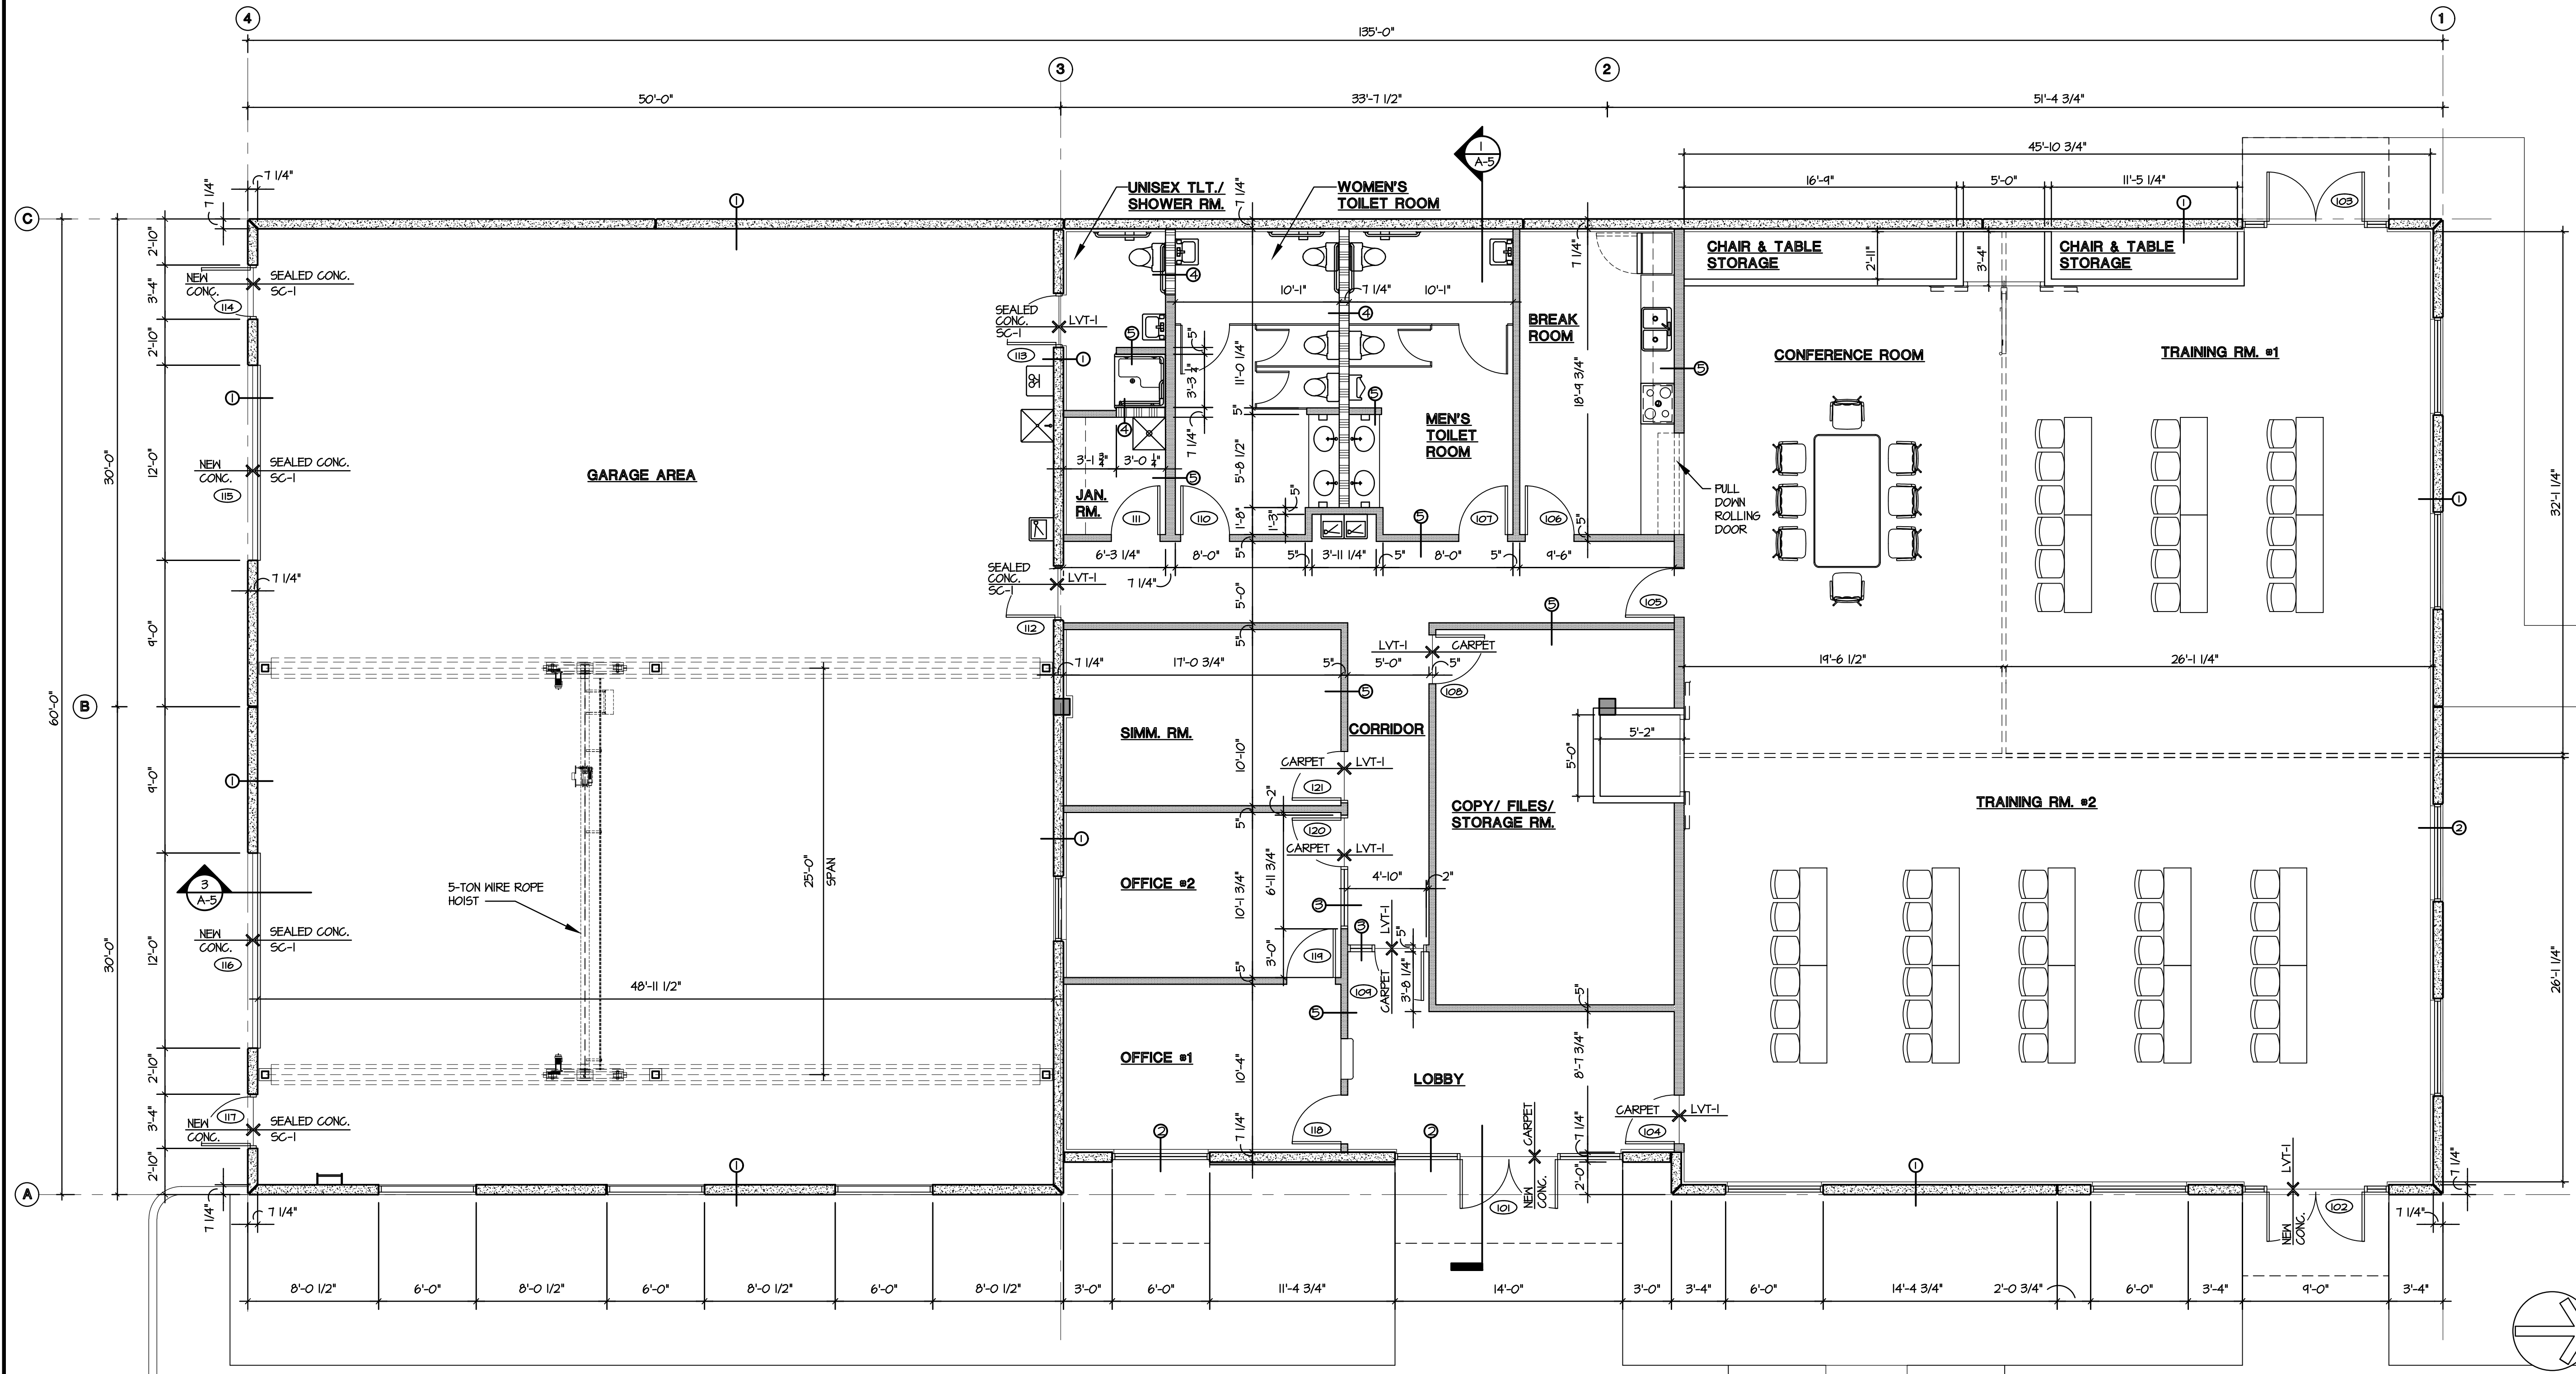

1 FLOOR PLAN - SCHEME "A"

SCALE: 3/16" = 30'-0"